


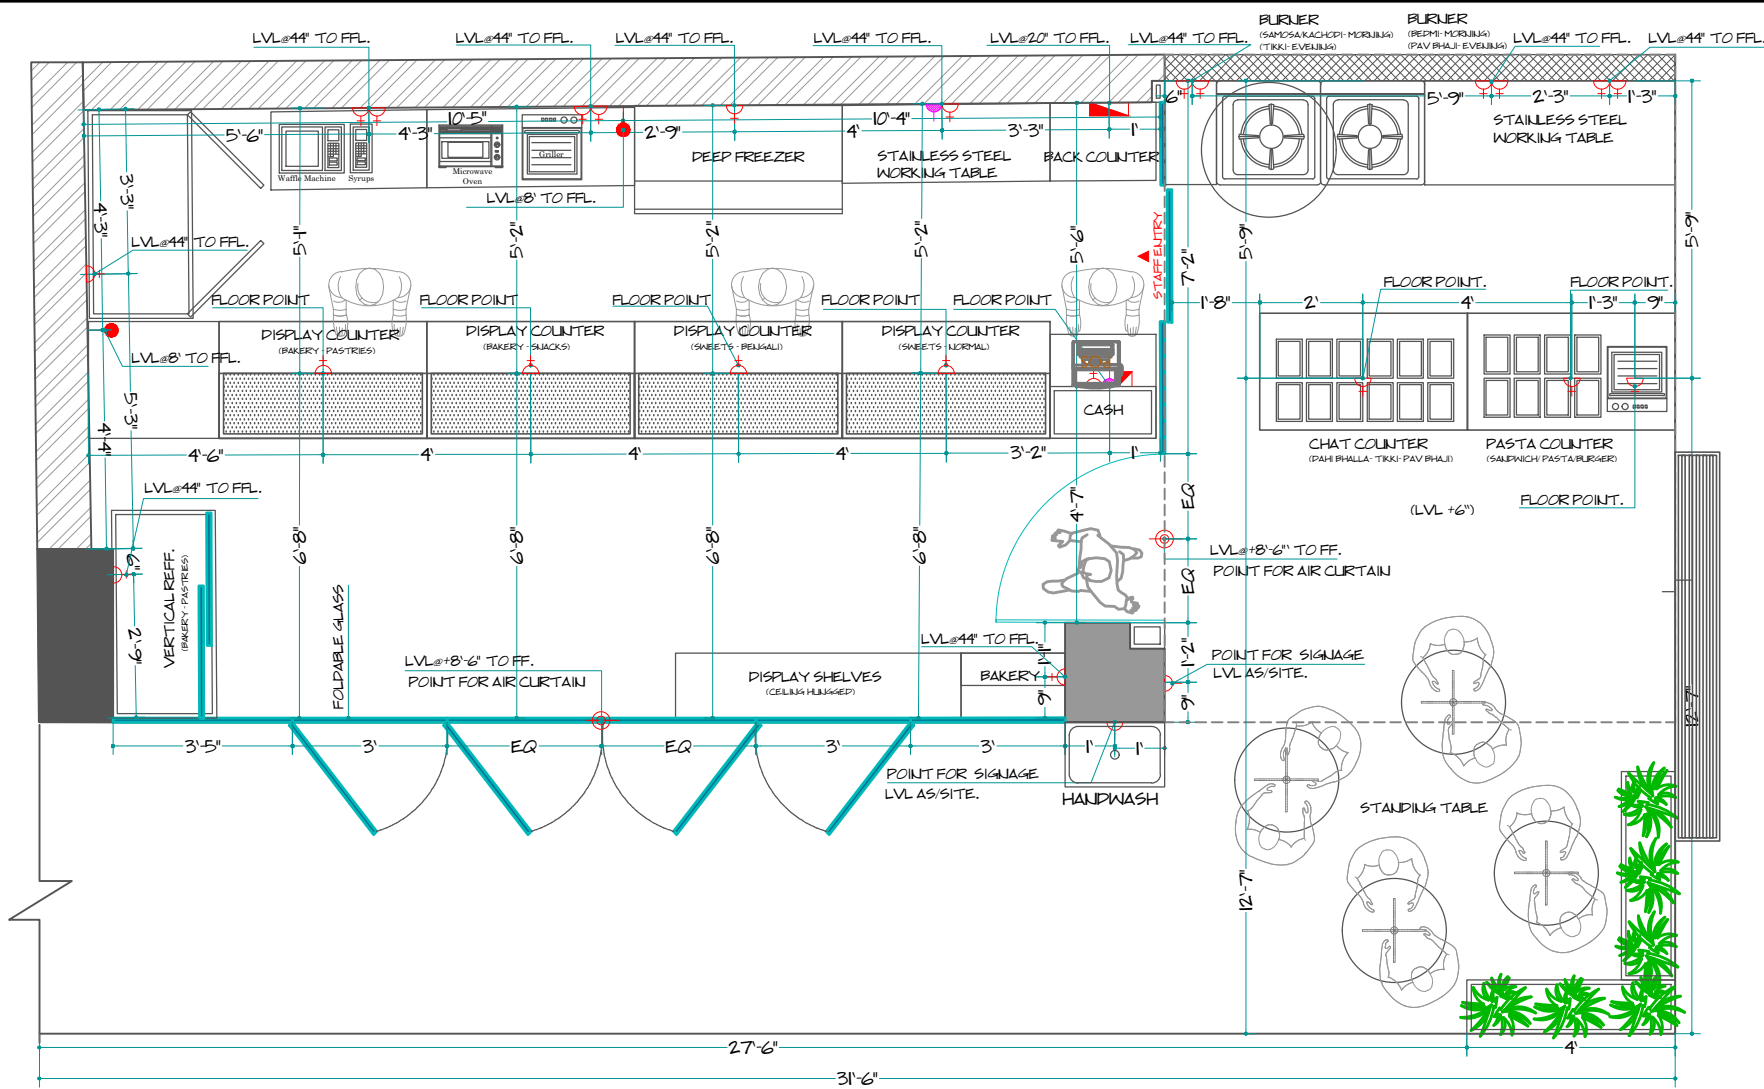

ELECTRICAL LAYOUT

ELECTRICAL LEGEND:-		
S.NO.	SYMBOL	DESCRIPTION
01.		DISTRIBUTION BOARD
02.		1 NO. 16A UNIVERSAL SWITCH SOCKET
03.		1 NOS. 6AMP. UNIVERSAL SOCKET
04.		4 NOS. OF WALL POINT
05.		2 NOS. 6AMP. UNIVERSAL SOCKET
06.		1 NOS. DATA & 1 NOS. VOICE

PROJECT
AMAIRA
(MUKHERJEE NAGAR, DELHI)

NOTE:
THIS DRAWING & DESIGN IS THE COPYRIGHT OF THE DESIGNER. NO PORTION MAY BE REPRODUCED WITHOUT THE WRITTEN PERMISSION OF THE DESIGNERS
1. ALL DIMENSIONS ARE INCLUDING FINISHES
2. DO NOT SCALE DRAWING. ONLY MENTIONED DIMENSIONS ARE TO BE CONSIDERED.
3. ALL DIMENSIONS MUST BE CHECKED BEFORE COMMENCING WORK ON SITE.
4. ANY DISCREPANCIES SHALL BE BROUGHT UNDER THE NOTICE OF ARCHITECTS PRIOR COMMENCEMENT OF WORK.

RELEASED FOR:

Information	tender	construction	as built
-------------	--------	--------------	----------

FOR CONSTRUCTION ONLY

REVISION

S.NO.	REMARKS	DATE

TITLE
ELECTRICAL LAYOUT

DATE	02-04-2019	
SCALE		
DRAWN BY	MUKESH	
CHD BY	PRIYANKA	
DWG. NO.	WD/SP/01/02019	

CONSULTANT

CONSULTANT

ARCHITECT/ INTERIOR DESIGN
PROSPECTIVE DESIGNS
B-39, First Floor, Kaushambi,
Ghaziabad, UP-201010.
tel/fax: 0120-4508600
e-mail: prospsdes@gmail.com